



WASTE AND VENT RISER DIAGRAM
NOT TO SCALE

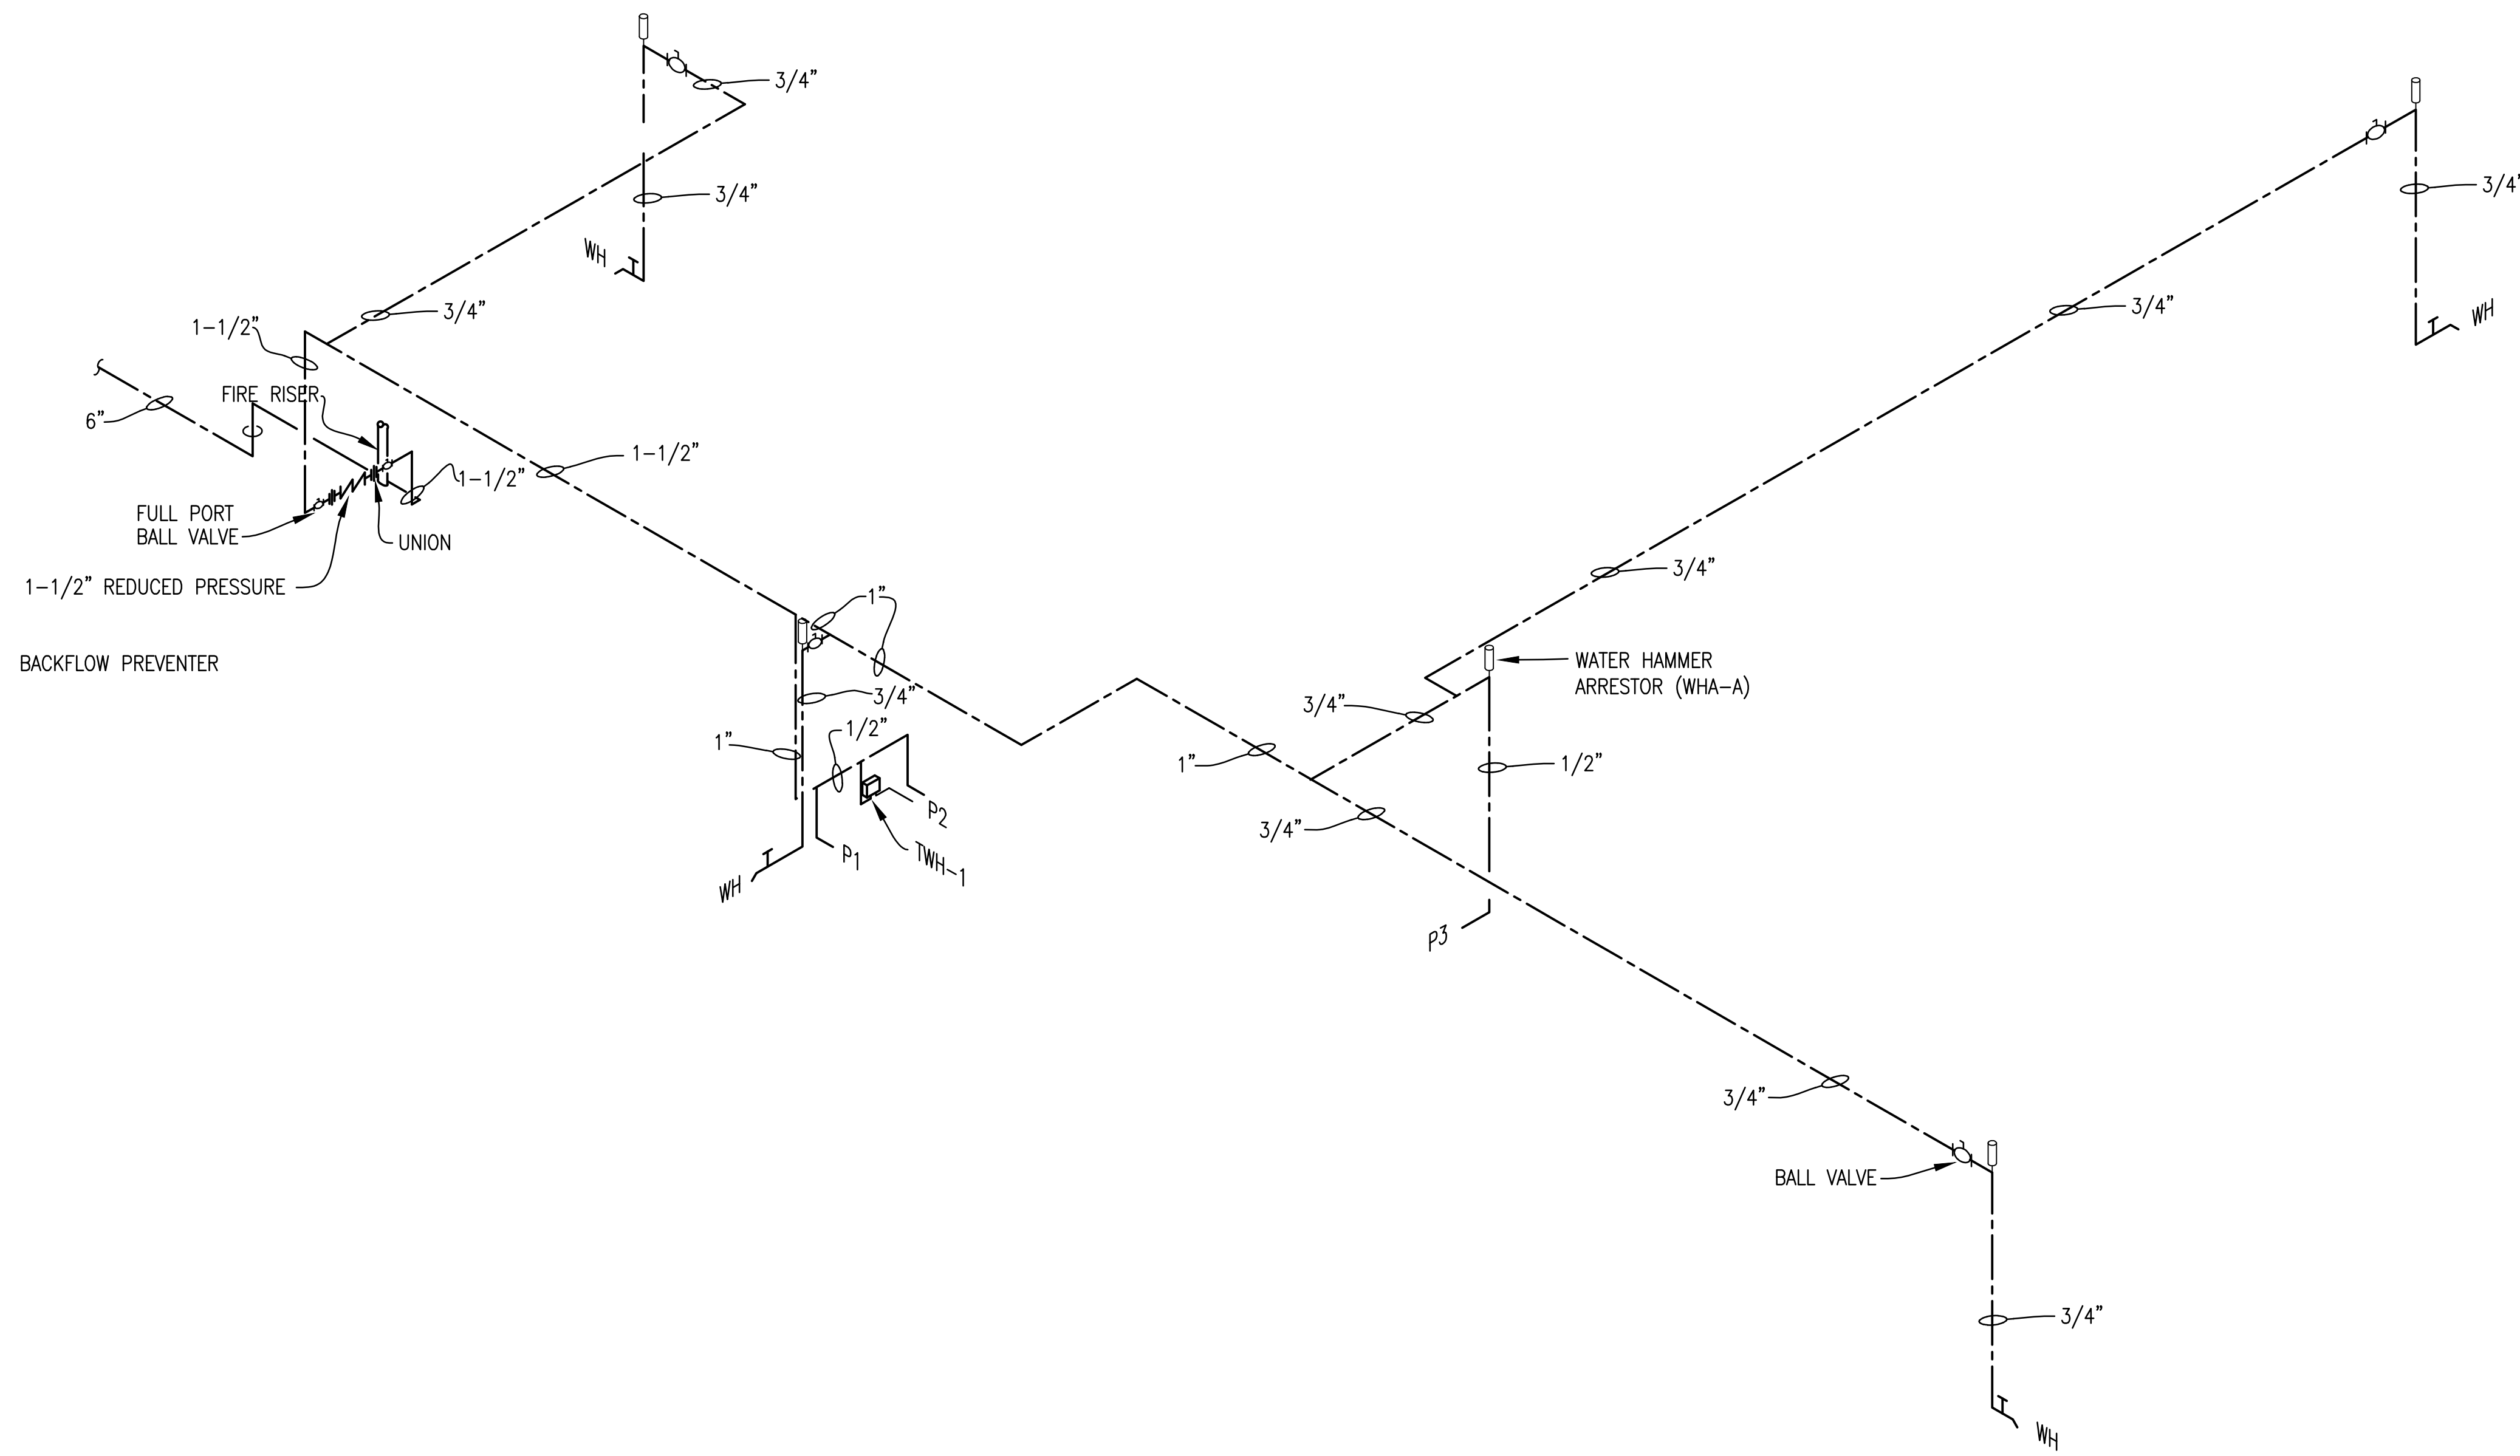

WATER RISER DIAGRAM
NOT TO SCALE

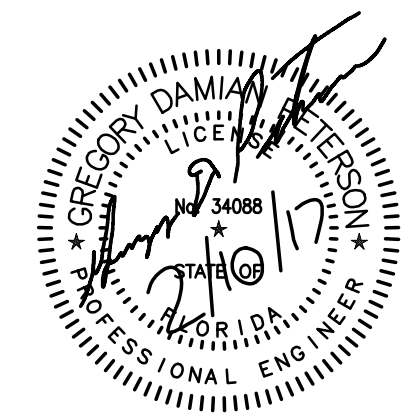

FINAL — FOR CONSTRUCTION

APP'D	
DESCRIPTION	
DATE	
REV #	
APPROVED	
CHIEF ENGINEER	
CIVIL ENGINEER	
CONSTRUCT TRAINING FACILITY, 2 CSWW BUILDING 91068	
PLUMBING SCHEDULES, LEGEND AND NOTES	
AIR FORCE SPECIAL OPERATIONS COMMAND 1 SPECIAL OPERATIONS CIVIL ENGINEER SQUADRON HURLBURT FIELD, FLORIDA	
DATE:	14 FEB 2017
DESIGNED BY:	GDP
DRAWN BY:	CAJ
BUILDING NO.:	91068
PROJECT NO.:	FTEV16-1066
SHEET REF.:	P601
SHEET NO.:	27 OF 48