


UPGRADE FIRE ALARM SYSTEM DORM 90369 & 90358 HURLBURT FIELD, FLORIDA CP1018248 (FTEV 10-1189)

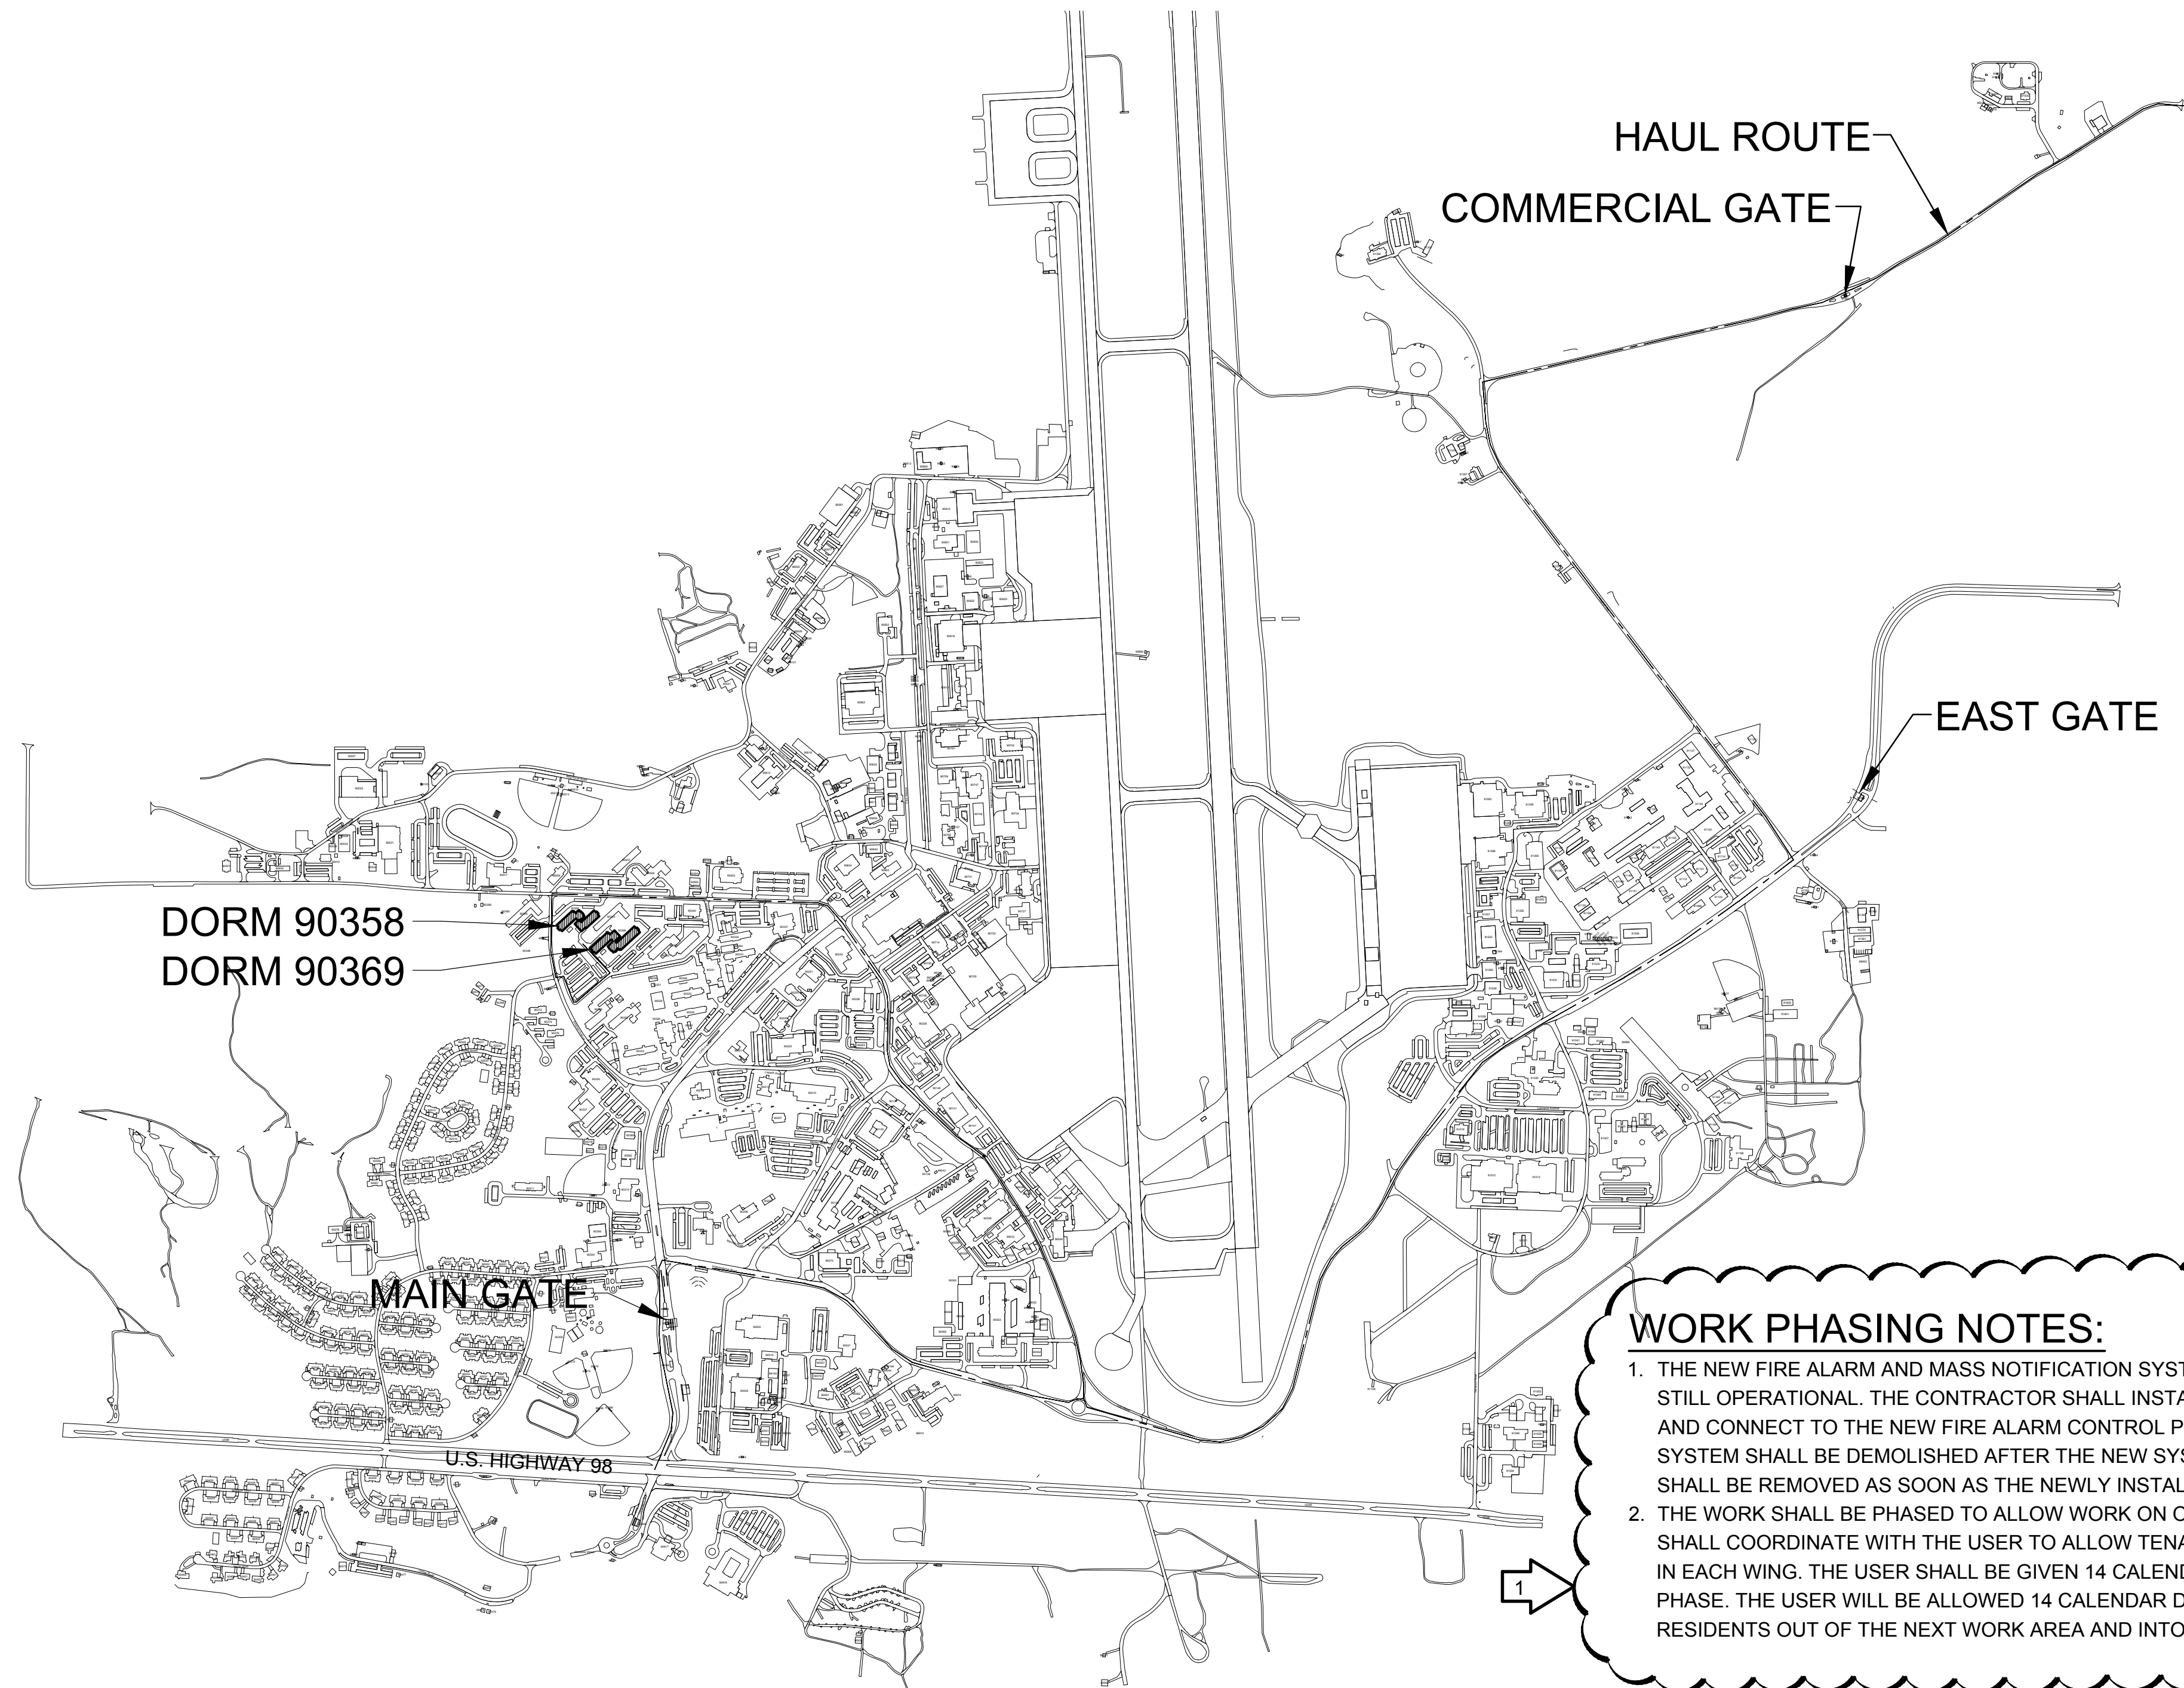


INDEX OF DRAWINGS	
SHEET #	TITLE
T-001	LOCATION MAP & INDEX OF DRAWINGS
M-101	HVAC PLANS - BLDG. 90358
M-102	HVAC PLANS - BLDG. 90369
F-001	FIRE ALARM & MASS NOTIFICATION SYSTEM LEGENDS
F-101	FIRE ALARM PLANS - DORM 90358 - FIRST FLOOR - DEMOLITION
F-102	FIRE ALARM PLANS - DORM 90358 - SECOND FLOOR - DEMOLITION
F-103	FIRE ALARM PLANS - DORM 90358 - THIRD FLOOR - DEMOLITION
F-104	FIRE ALARM PLAN - DORM 90369 - FIRST FLOOR WING 'A' - DEMOLITION
F-105	FIRE ALARM PLAN - DORM 90369 - FIRST FLOOR WING 'B' - DEMOLITION
F-106	FIRE ALARM PLANS - DORM 90369 - SECOND FLOOR - DEMOLITION
F-107	FIRE ALARM PLANS - DORM 90369 - THIRD FLOOR - DEMOLITION
F-201	FIRE ALARM PLANS - DORM 90358 - FIRST FLOOR - NEW WORK
F-202	FIRE ALARM PLANS - DORM 90358 - SECOND FLOOR - NEW WORK
F-203	FIRE ALARM PLANS - DORM 90358 - THIRD FLOOR - NEW WORK
F-204	FIRE ALARM PLAN - DORM 90369 - FIRST FLOOR WING 'A' - NEW WORK
F-205	FIRE ALARM PLAN - DORM 90369 - FIRST FLOOR WING 'B' - NEW WORK
F-206	FIRE ALARM PLANS - DORM 90369 - SECOND FLOOR - NEW WORK
F-207	FIRE ALARM PLANS - DORM 90369 - THIRD FLOOR - NEW WORK
F-601	FIRE ALARM & MASS NOTIFICATION SYSTEM DISTRIBUTION DIAGRAM - DORM 90358
F-602	FIRE ALARM & MASS NOTIFICATION RISER DIAGRAM - DORM 90358 - INITIATING DEVICES
F-603	FIRE ALARM & MASS NOTIFICATION RISER DIAGRAM - DORM 90358 - VISUAL DEVICES
F-604	FIRE ALARM & MASS NOTIFICATION RISER DIAGRAM - DORM 90358 - AUDIBLE DEVICES
F-605	FIRE ALARM & MASS NOTIFICATION SYSTEM DISTRIBUTION DIAGRAM - DORM 90369
F-606	FIRE ALARM & MASS NOTIFICATION RISER DIAGRAM - DORM 90369 - INITIATING DEVICES
F-607	FIRE ALARM & MASS NOTIFICATION RISER DIAGRAM - DORM 90369 - VISUAL DEVICES
F-608	FIRE ALARM & MASS NOTIFICATION RISER DIAGRAM - DORM 90369 - AUDIBLE DEVICES
E-200	ELECTRICAL PLANS - POWER - NEW WORK


WORK PHASING NOTES:

1. THE NEW FIRE ALARM AND MASS NOTIFICATION SYSTEMS SHALL BE INSTALLED WHILE THE EXISTING FIRE ALARM SYSTEM IS STILL OPERATIONAL. THE CONTRACTOR SHALL INSTALL A MONITOR MODULE AT THE EXISTING FIRE ALARM CONTROL PANEL AND CONNECT TO THE NEW FIRE ALARM CONTROL PANEL TO TRIP BOTH PANELS IN THE EVENT OF AN ALARM. THE EXISTING SYSTEM SHALL BE DEMOLISHED AFTER THE NEW SYSTEM IS FUNCTIONAL. THE EXISTING DEVICES IN THE DORM ROOMS SHALL BE REMOVED AS SOON AS THE NEWLY INSTALLED DEVICES IN THE DORM ROOMS ARE FUNCTIONAL.
2. THE WORK SHALL BE PHASED TO ALLOW WORK ON ONE WING PER FLOOR, PER BUILDING AT A TIME. THE CONTRACTOR SHALL COORDINATE WITH THE USER TO ALLOW TENANTS TO BE RELOCATED PRIOR TO THE BEGINNING OF CONSTRUCTION IN EACH WING. THE USER SHALL BE GIVEN 14 CALENDAR DAYS ADVANCE NOTICE PRIOR TO THE END OF WORK IN EACH PHASE. THE USER WILL BE ALLOWED 14 CALENDAR DAYS FROM COMPLETION OF THE PREVIOUS PHASE TO MOVE RESIDENTS OUT OF THE NEXT WORK AREA AND INTO THE RECENTLY COMPLETED WORK AREA.


LOCATION MAP
 N.T.S.

PETERSON ENGINEERING INC.
 75 SOUTH "F" STREET
 PENSACOLA, FLORIDA 32502
 (850) 434-0513

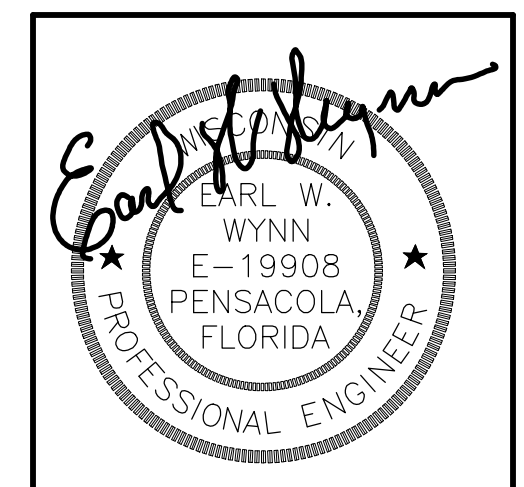

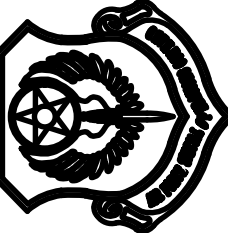REV #	DATE	DESCRIPTION
1	6/12/18	REVISED WORK PHASING NOTE
UPGRADE FIRE ALARM SYSTEM		
DORM 90369 & 90358		
LOCATION MAP & INDEX OF DRAWINGS		
AIR FORCE SPECIAL OPERATIONS COMMAND		
1 SPECIAL OPERATIONS CIVIL ENGINEER SQUADRON		
HURLBURT FIELD, FLORIDA		
		
DATE:		
7 FEB 2018		
DESIGNED BY:		
EWWW/JRH		
DRAWN BY:		
JRH		
BUILDING NUMBER:		
90358 & 90369		
PROJECT NUMBER:		
CP1018248		
SHEET REFERENCE:		
T-001		
SHEET NUMBER:		
1 OF 27		