

**PROJECT ISSUES:**

RFP PRICING DRAWINGS	2022-09-10
RFP SUNSHADE DIMENSIONS	2022-09-12

**PROJECT TEAM:**

ARCHITECTURAL  
 B&A ARCHITECTURAL GROUP  
 STRUCTURAL  
 tbd

**PROJECT:**

DESIGN-BUILD HONOR  
 GUARD FACILITY

TYNDALL AFB, FLORIDA

**-PRELIMINARY-  
 NOT FOR  
 CONSTRUCTION**

PROJECT NO. : 22048  
 SHEET TITLE:  
 FLOOR PLAN


SHEET NUMBER:

**M101**


RFP PRICING DRAWINGS

**NOTE:**  
 1. ALL DUCT SIZES ARE FLAT OVAL OR SPIRAL PER UFC.  
 2. ALL SUPPLY GRILLES WILL BE 2X2 PLAQUE TYPE, ALL RETURN AND EXHAUST ARE EGG-CRATE.  
 3. ALL VAV TERMINAL UNITS HAVE ELECTRIC REHEAT COILS.

- Supply duct
- Return duct
- Exhaust duct
- OA Supply duct
- Refrigerant Piping

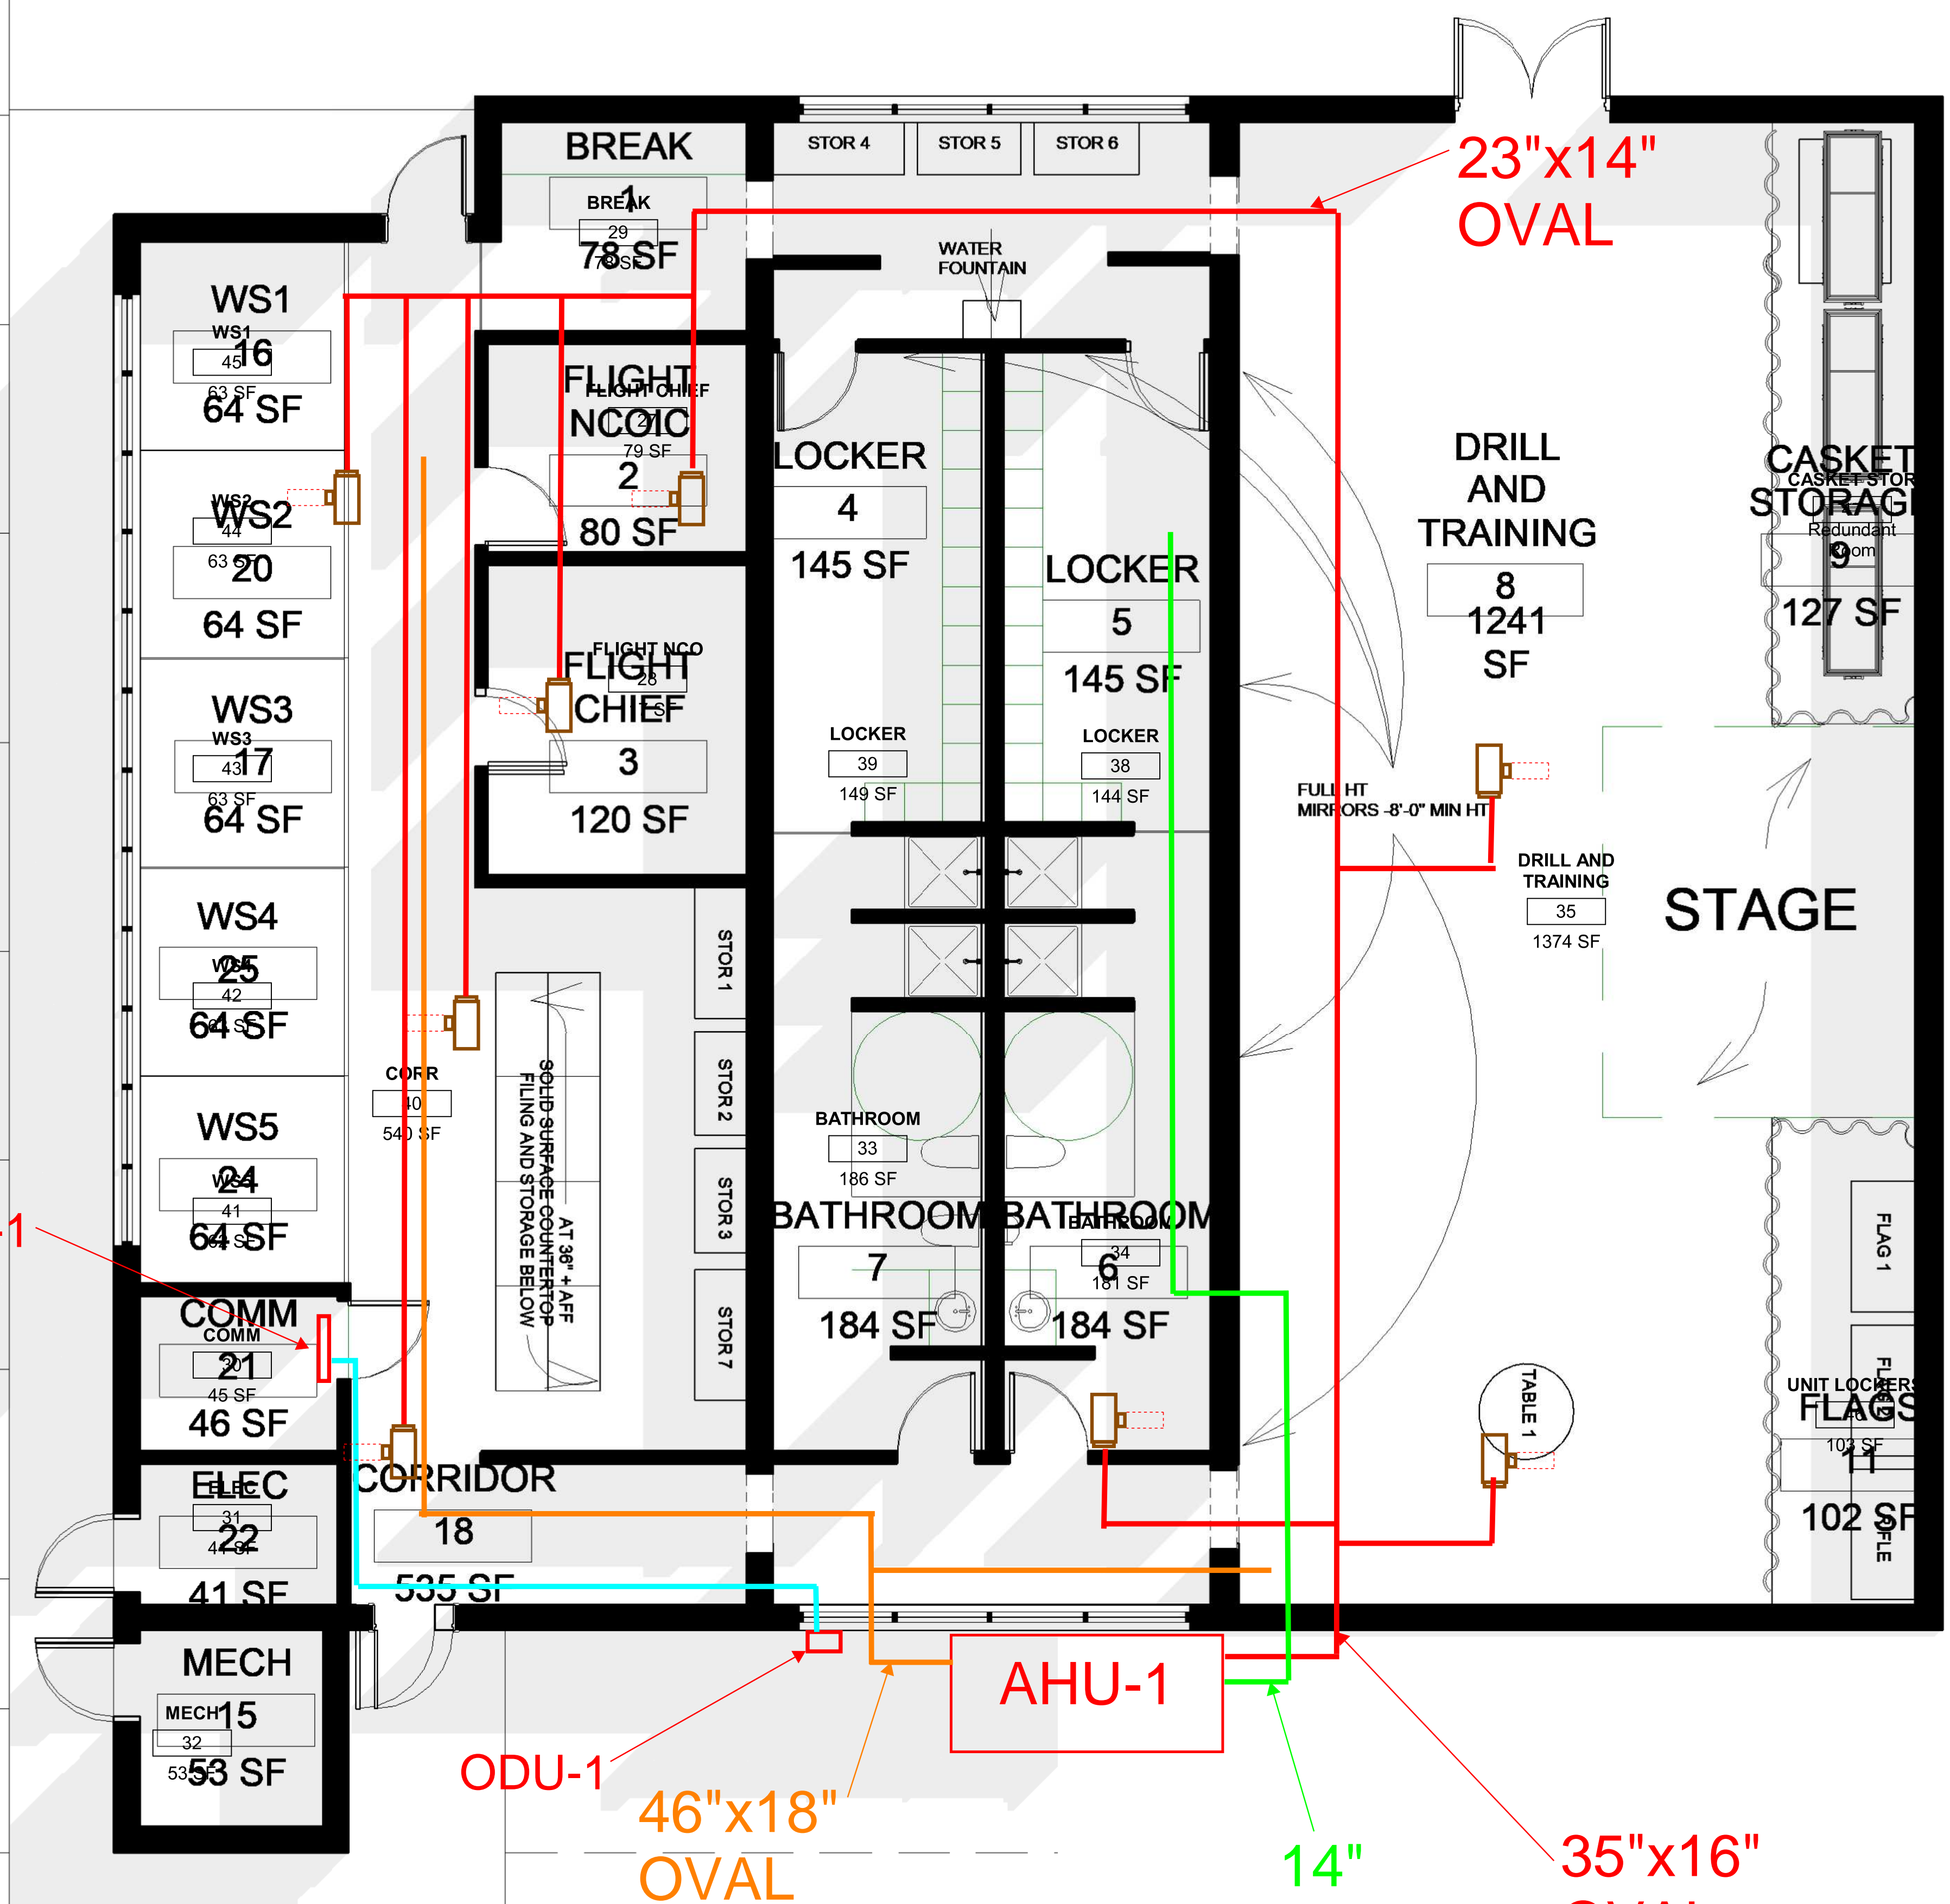

PRINT DATE: 9/13/2022 10:27:14 AM

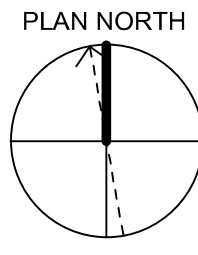

**1**  
 M200 M101  
 1/4" = 1'-0"

**MECHANICAL FLOOR PLAN**