

PROJECT ISSUES:

RFP PRICING DRAWINGS	2022-09-10
RFP SUNSHADE DIMENSIONS	2022-09-12

PROJECT TEAM:

ARCHITECTURAL
 B&A ARCHITECTURAL GROUP
 STRUCTURAL
 tbd

PROJECT:

DESIGN-BUILD HONOR
 GUARD FACILITY


TYNDALL AFB, FLORIDA

PROJECT NO. : 22048
 SHEET TITLE:
 FLOOR PLAN

SHEET NUMBER:

P101

RFP PRICING DRAWINGS

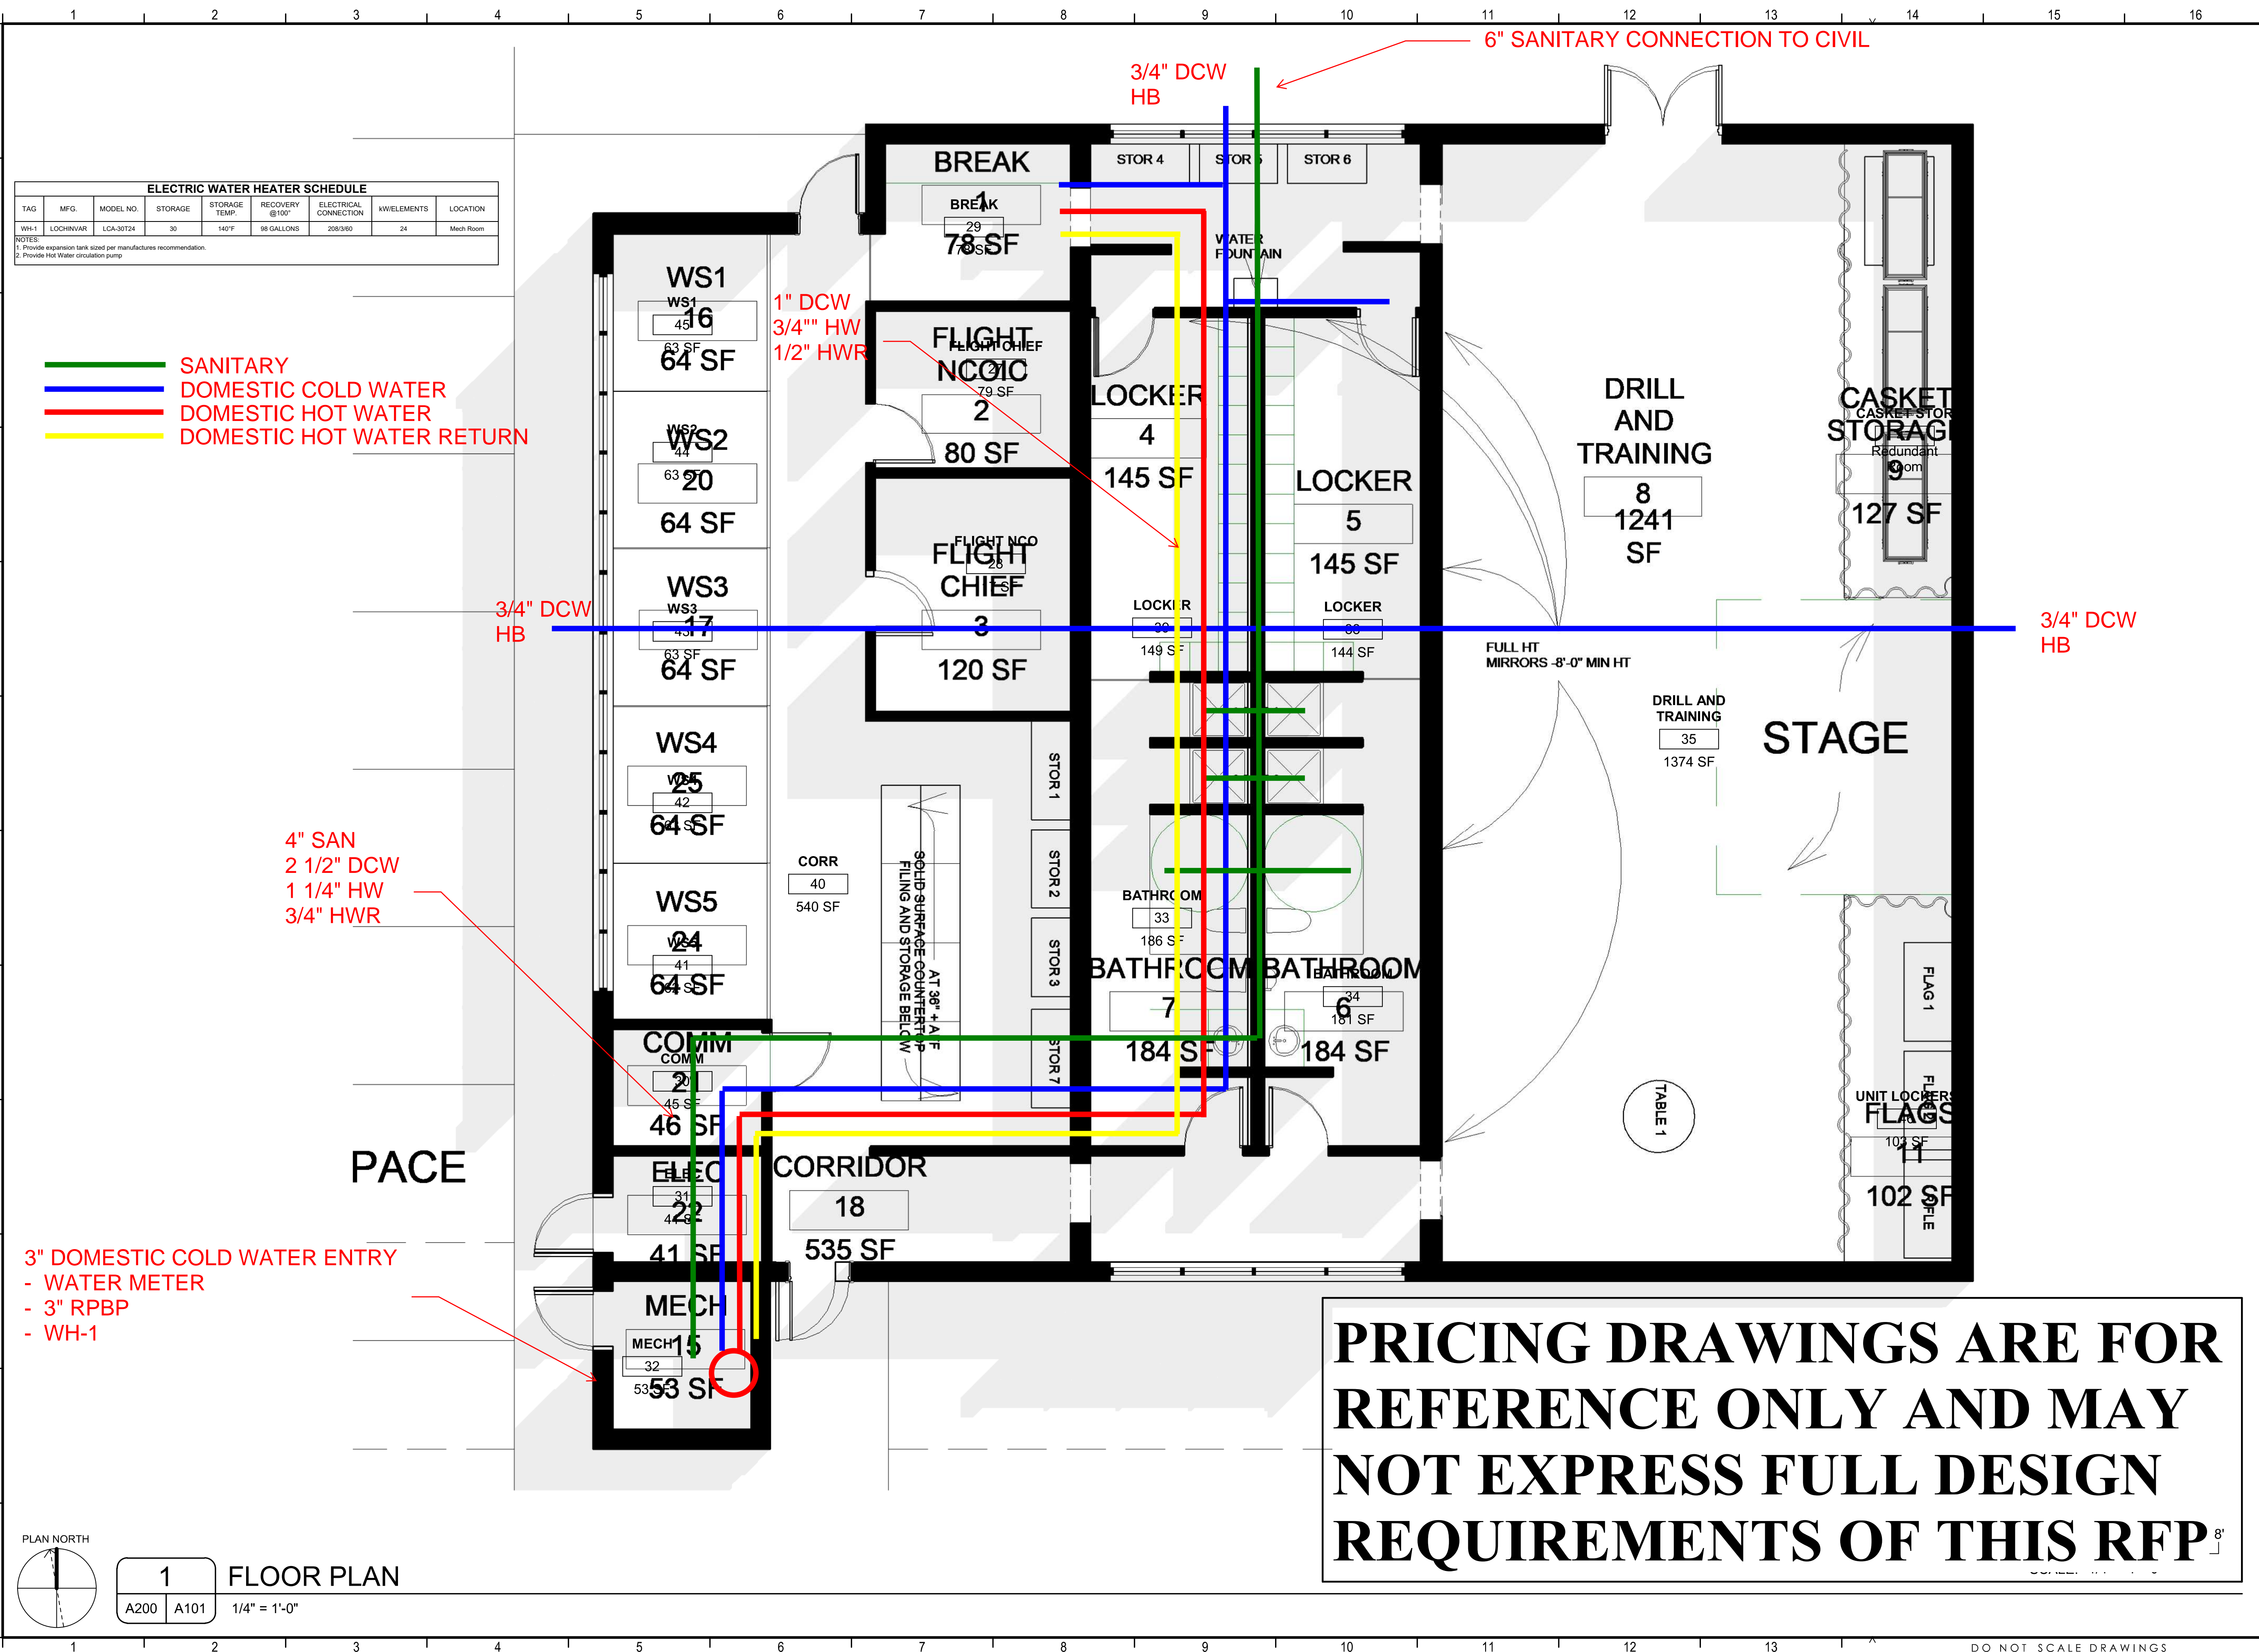

ELECTRIC WATER HEATER SCHEDULE								
TAG	MFG.	MODEL NO.	STORAGE	STORAGE TEMP.	RECOVERY @100'	ELECTRICAL CONNECTION	KW/ELEMENTS	LOCATION
WH-1	LOCHINVAR	LCA-38724	30	140°F	98 GALLONS	208/3/60	24	Mech Room

NOTES:
 1. Provide expansion tank sized per manufactures recommendation.
 2. Provide Hot Water circulation pump.

— SANITARY
— DOMESTIC COLD WATER
— DOMESTIC HOT WATER
— DOMESTIC HOT WATER RETURN

4" SAN
 2 1/2" DCW
 1 1/4" HW
 3/4" HWR

3" DOMESTIC COLD WATER ENTRY
 - WATER METER
 - 3" RPBP
 - WH-1

PLAN NORTH

1	FLOOR PLAN
A200	A101

1/4" = 1'-0"

PRICING DRAWINGS ARE FOR REFERENCE ONLY AND MAY NOT EXPRESS FULL DESIGN REQUIREMENTS OF THIS RFP

**-PRELIMINARY-
 NOT FOR
 CONSTRUCTION**

PRINT DATE: 9/13/2022 10:27:14 AM