

**PROJECT ISSUES:**

RFP PRICING DRAWINGS 2022-09-10  
 RFP SUNSHADE DIMENSIONS 2022-09-12

**PROJECT TEAM:**  
 ARCHITECTURAL B&A ARCHITECTURAL GROUP  
 STRUCTURAL tbd

**PROJECT:**  
 DESIGN-BUILD HONOR GUARD FACILITY

**TYNDALL AFB, FLORIDA**


**-PRELIMINARY- NOT FOR CONSTRUCTION**

PROJECT NO. : 22048  
 SHEET TITLE: FLOOR PLAN

SHEET NUMBER:

**T101**


**PRICING DRAWINGS ARE FOR REFERENCE ONLY AND MAY NOT EXPRESS FULL DESIGN REQUIREMENTS OF THIS RFP**

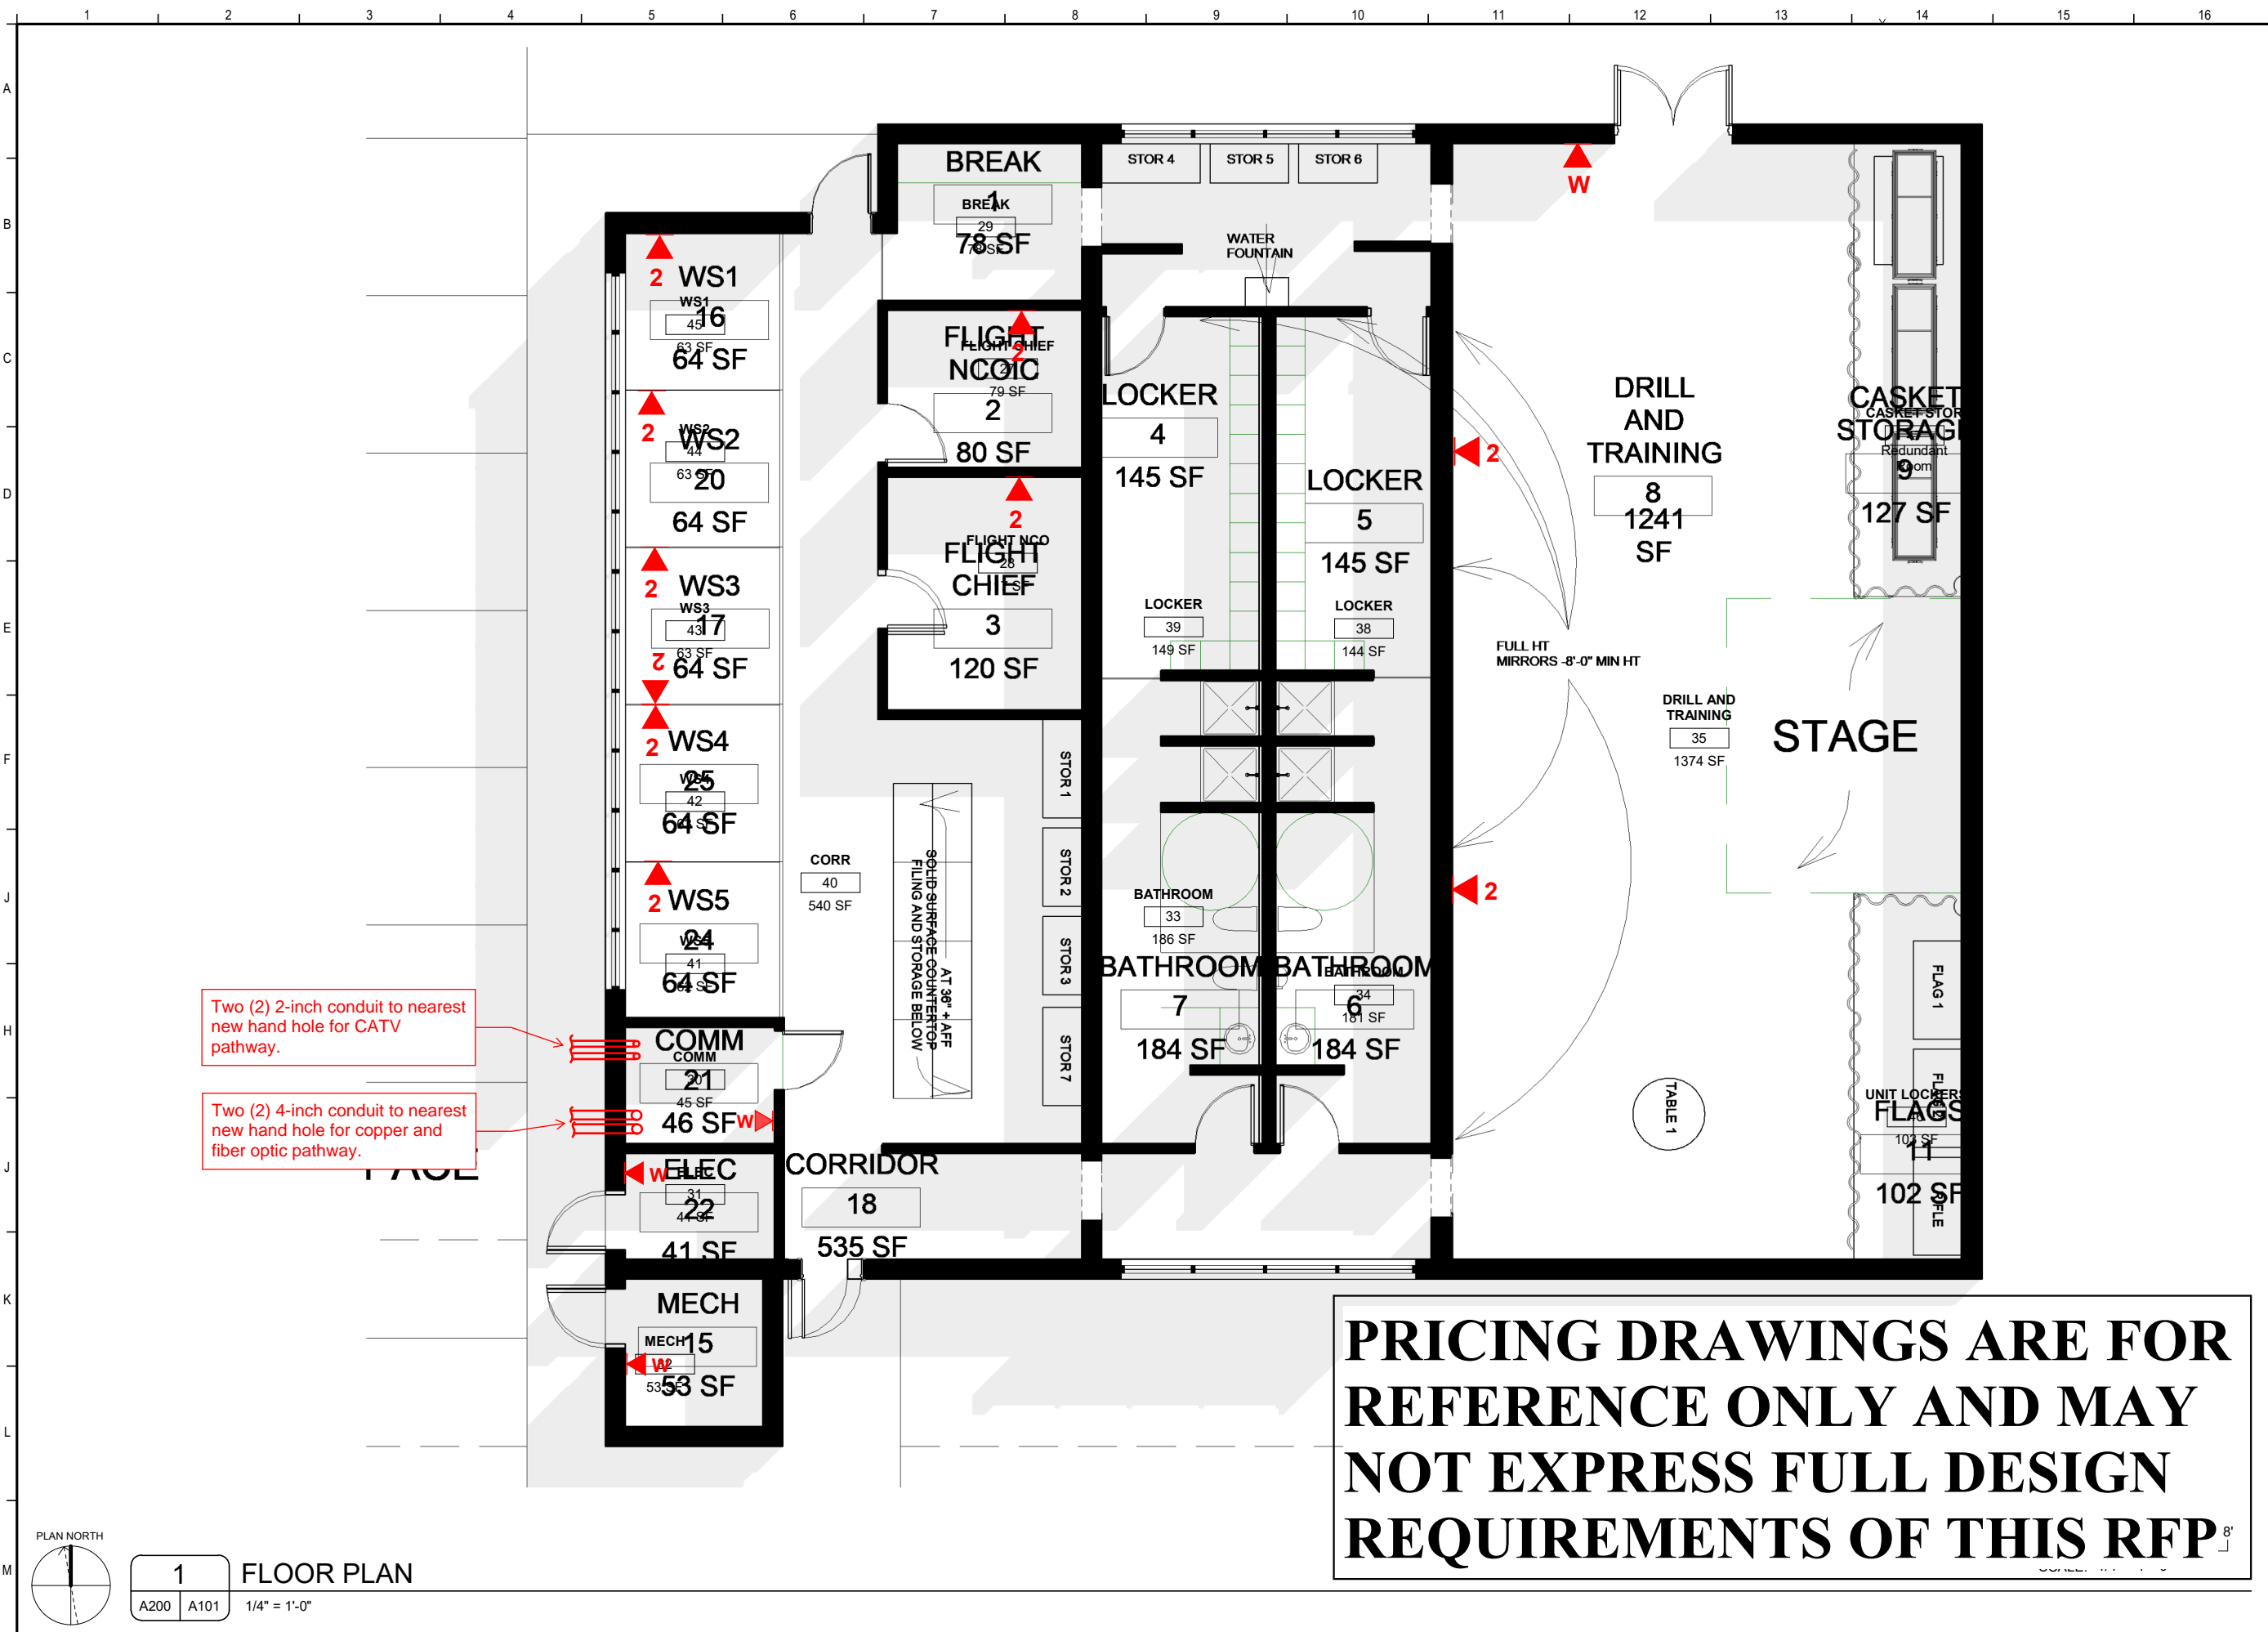

Two (2) 2-inch conduit to nearest new hand hole for CATV pathway.

Two (2) 4-inch conduit to nearest new hand hole for copper and fiber optic pathway.

 PLAN NORTH



**1 FLOOR PLAN**  
 A200 A101 1/4" = 1'-0"

PRINT DATE: 9/13/2022 10:27:14 AM